


8 BED WET SLEEPER

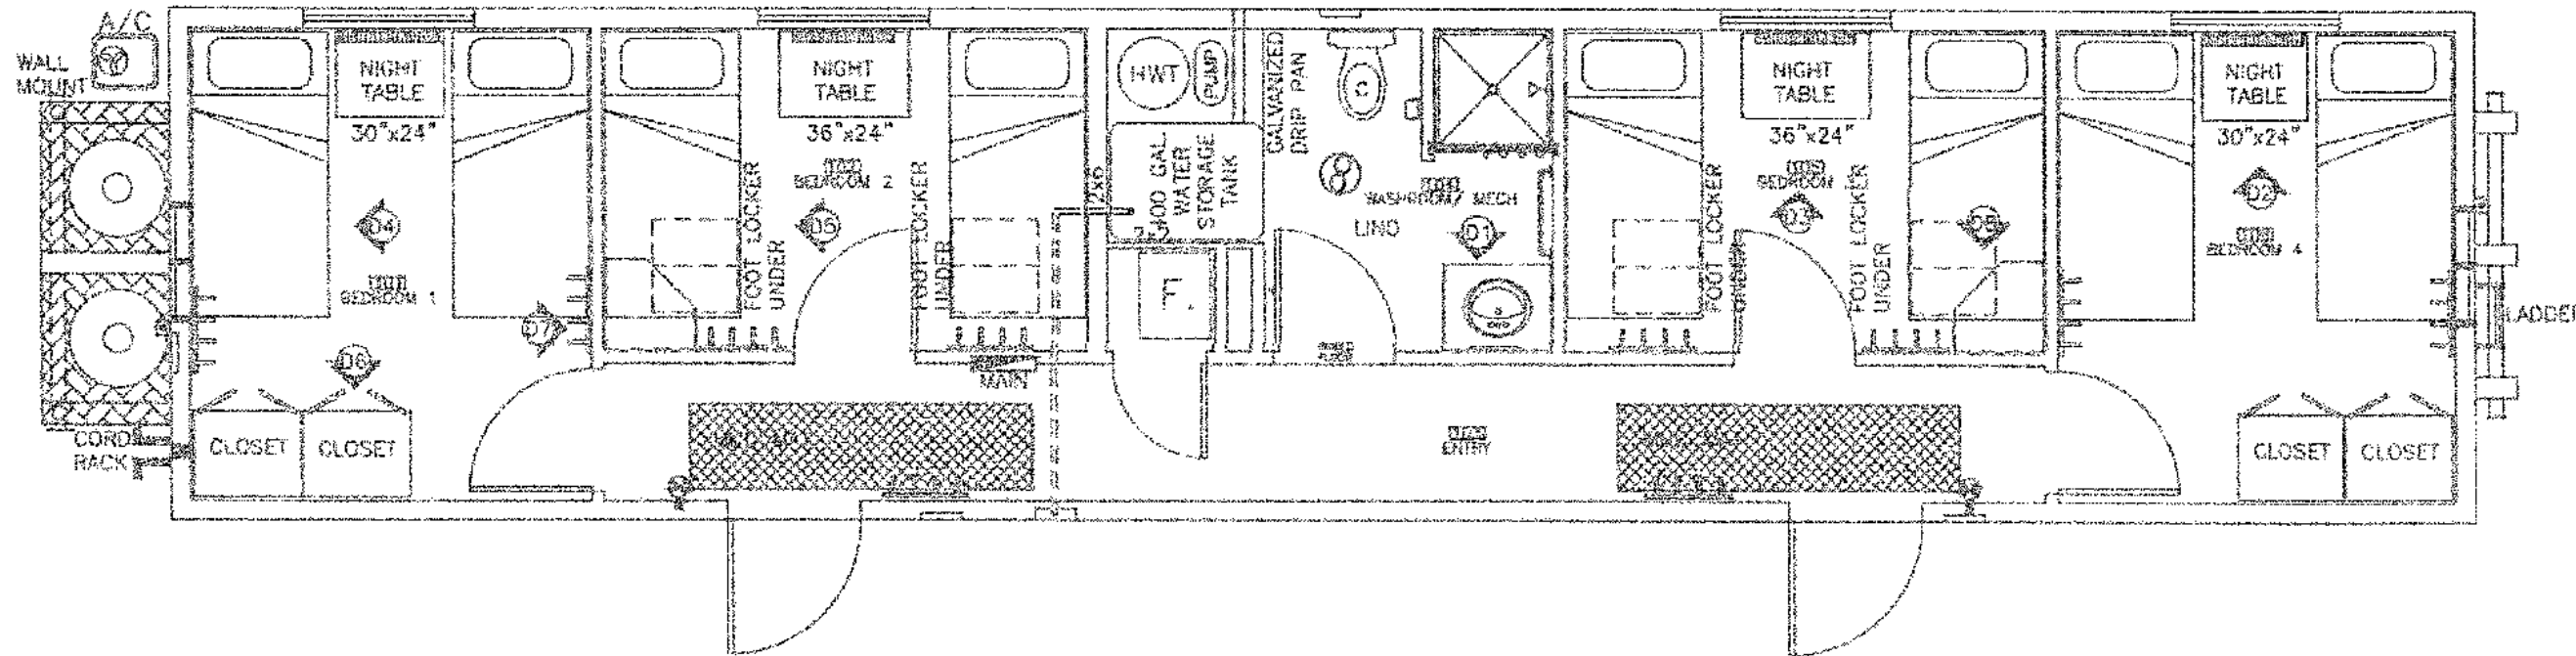

Parkland Modular
 Equipment & Brokerage LTD.
 30 Alberta Ave
 Spruce Grove AB
 T7X 3B3 | (780) 656-8562



no.	description	date	checked
revisions			

Seal:

Comments:

Client:

Project:
**10' X 32' SKIDDED
 OFFICE/BATHROOM**

Drawing:
MAIN FLOOR PLAN

Date:	Drawn By:
Scale: AS SHOWN	File:
Dimensions: INCHES	Drawing:
Job:	A-1
Program:	
Sheets:	