


8 UNIT DORM

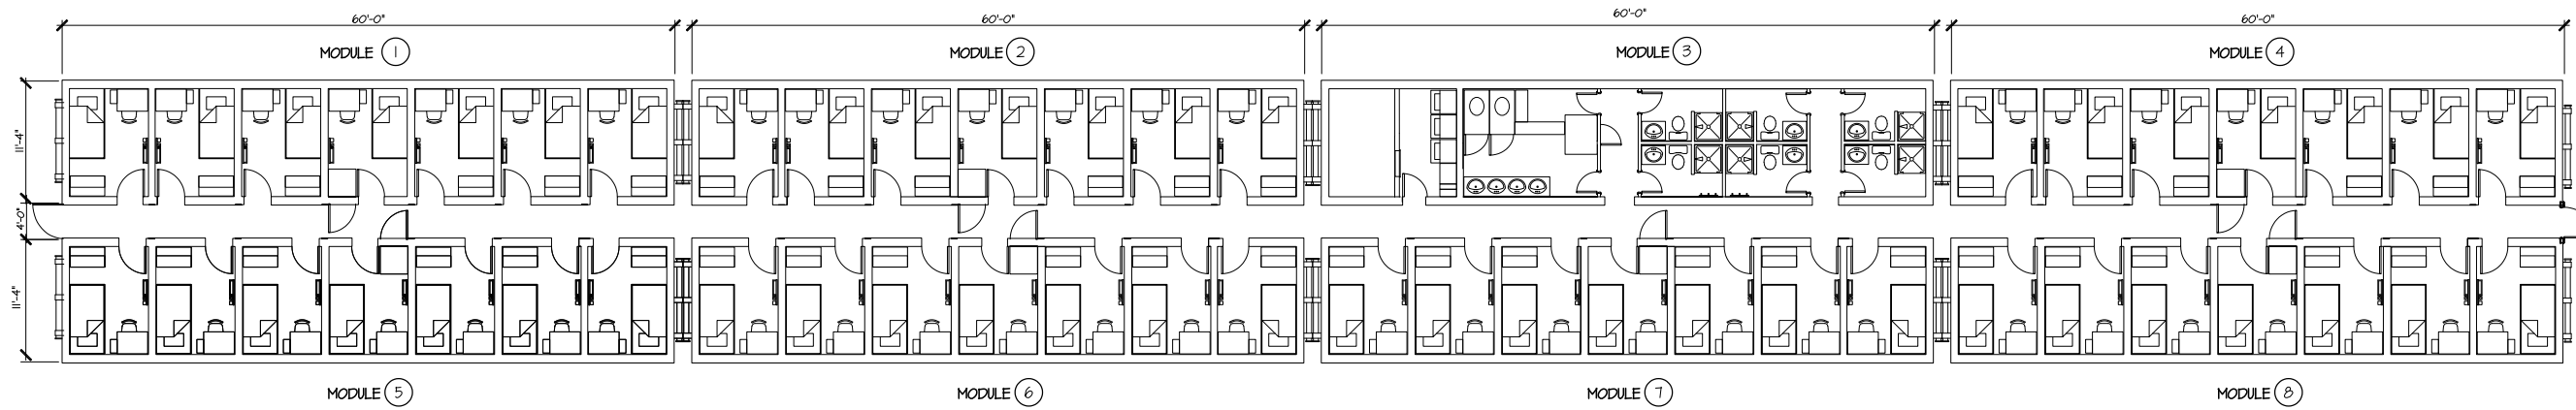

Parkland Modular
Equipment & Brokerage LTD.
30 Alberta Ave
Spruce Grove AB
T7X 3B3 | (780) 656-8562



no.	description	date	checked
revisions			

Seal:

Comments:

Client:

Project:
8 UNIT DORM

Drawing:
MAIN FLOOR PLAN

Date:	Drawn By:
Scale: AS SHOWN	File:
Dimensions: INCHES	Drawing: A-1
Job:	
Program:	
Sheets:	